


**SUBJECT TO FIRE MARSHAL APPROVAL**

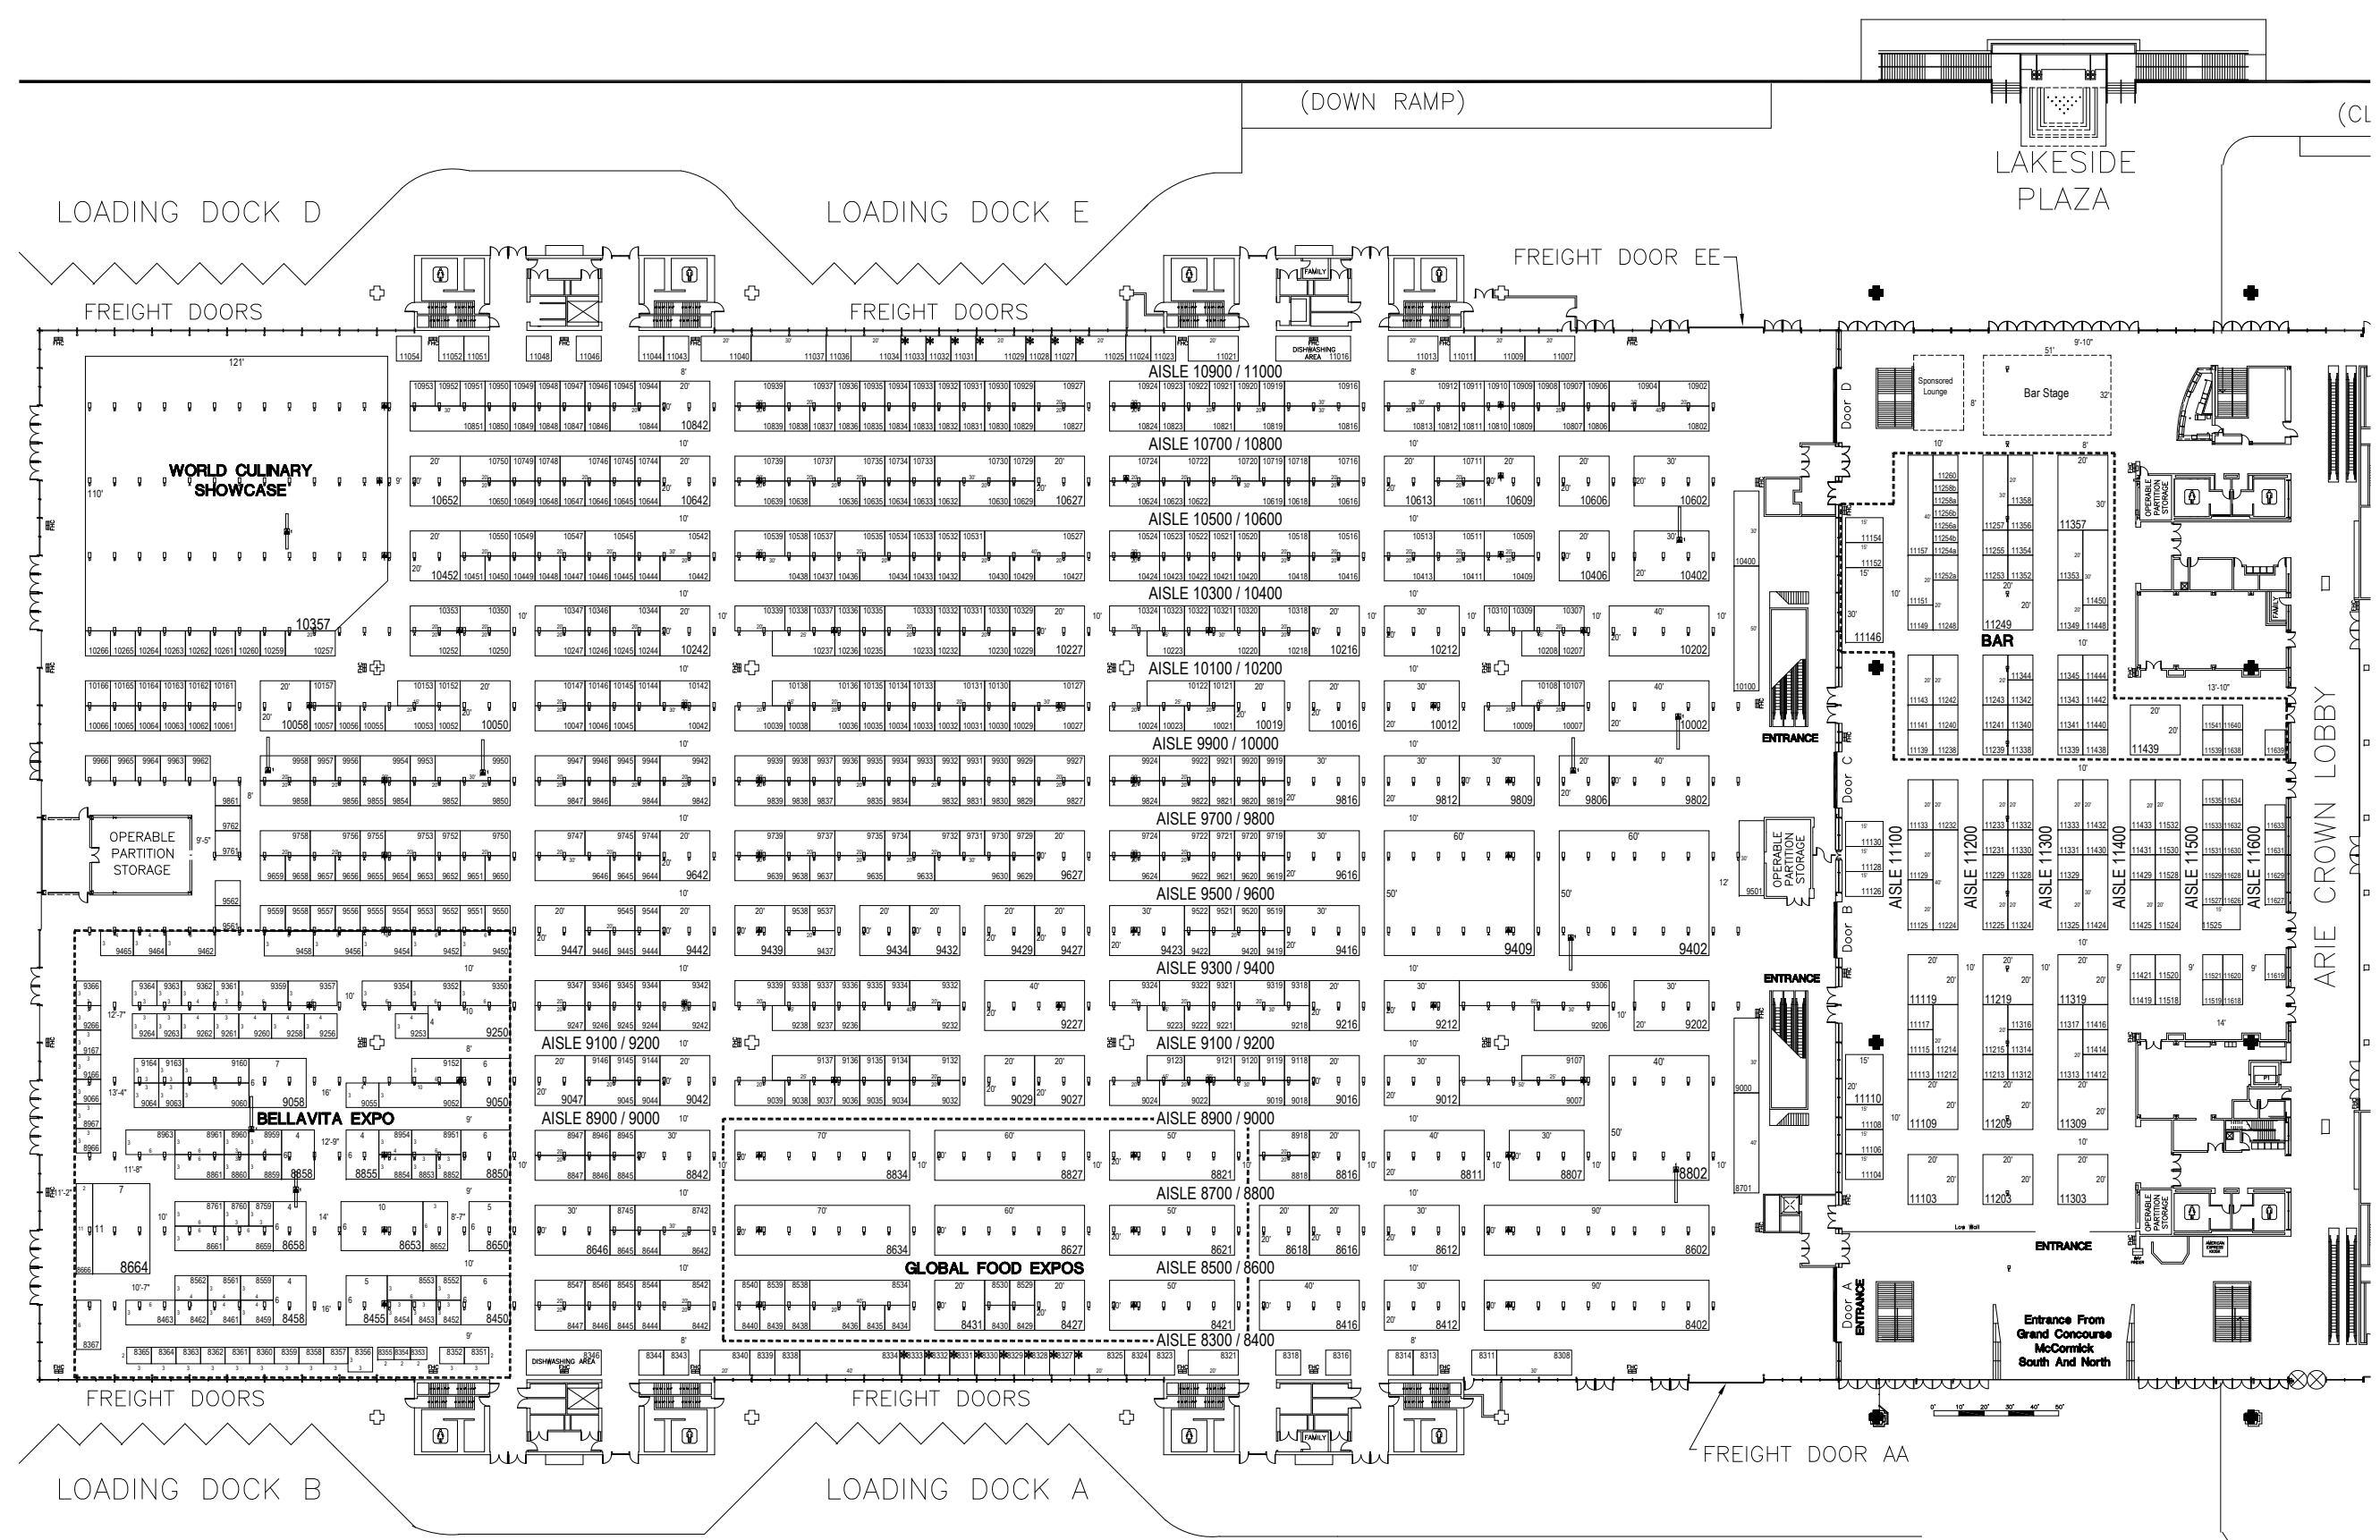

**BUILDING LEGEND**




- HALLS D1, D2 AND HALLROOM UTILITIES
- ELECTRICAL PANS
- A = 200V, THREE, SCAMP
- B = 120V, SINGLE, SCAMP
- C = 480V, THREE, SCAMP
- D = 120V, SINGLE, SCAMP
- E = 480V, THREE, SCAMP
- F = 200V, THREE, SCAMP
- G = 120V, SINGLE, SCAMP

**PLUMBING POINTS**

- 1 1" AIR, 1" GAS, 1" WATER, 4" WASTE
- 2 1" AIR, 1" GAS, 1" WATER, 4" WASTE, 2" STEAM
- 3 1" WASTE, 1" WASTE
- 4 1" AIR, 1" WATER, 1" WASTE

**CEILING HEIGHT = 50'**

- FHC FIRE HOSE CABINET (W/RE KEYP CLEAR)
- FRX FIRE EXTINGUISHER CABINET
- FR FIRE HOSE RACK
- \* INDICATES LAST VISITORS OUT

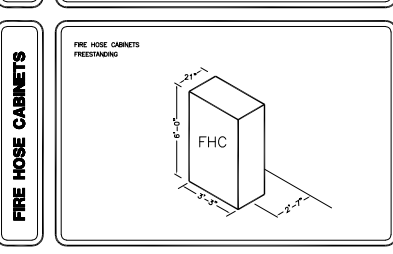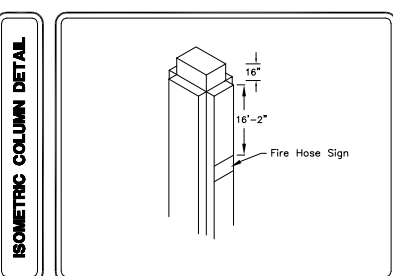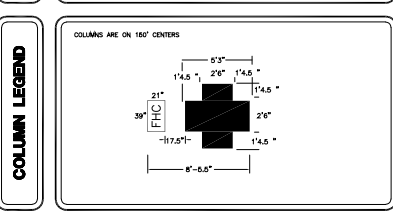

**FLOOR PLAN INFORMATION**

Show: NRA  
Date Of Show: May 18 - 21, 2019  
Facility: McCormick Place  
Portion Of Facility/Hall: Level 3 - Halls D1 & D2  
City: Chicago, IL  
Show Number:

Booth Size Unless Noted: 10'	Drawn By: Lisa Pizzato
Booth Size Unless Noted: 10'x10' SE/AE: John Lovelless	
Outline: z-mccorm-d1d2.dwg	
File: nra1-1905-mccorm-d1d2.dwg	
Initial: 04-02-18 LP	Rev:
Rev: 04-12-18 LP	Rev:
Rev: 04-26-18 LP	Rev:
Rev: 06-07-18 LP	Rev:
Rev: 11-06-18 LP	Rev:
Rev: 01-04-19 LP	Rev:
Rev:	Rev:

**GES**

Copyright © by Global Experience Specialists. All rights reserved. No part of this publication may be reproduced, stored in any retrieval system, or transmitted in any form or by any means - electronic, mechanical, photocopying, recording, or otherwise - without express written consent of Global Experience Specialists. Every effort has been made to insure the accuracy of all information contained on this floor plan. However, no warranties, either expressed or implied, are made with respect to this floor plan. If the location of building columns, utilities, or other architectural components of the facility is a consideration in the construction or usage of an exhibit, it is the sole responsibility of the exhibitor to physically inspect the facility to verify all dimensions and locations.

**CONFIDENTIAL PROPERTY OF GES  
SEE ABOVE**